


G » Á Ô Ò Þ V Ü Ò Á Ú Q V Ô Þ Á Ü U U Ø

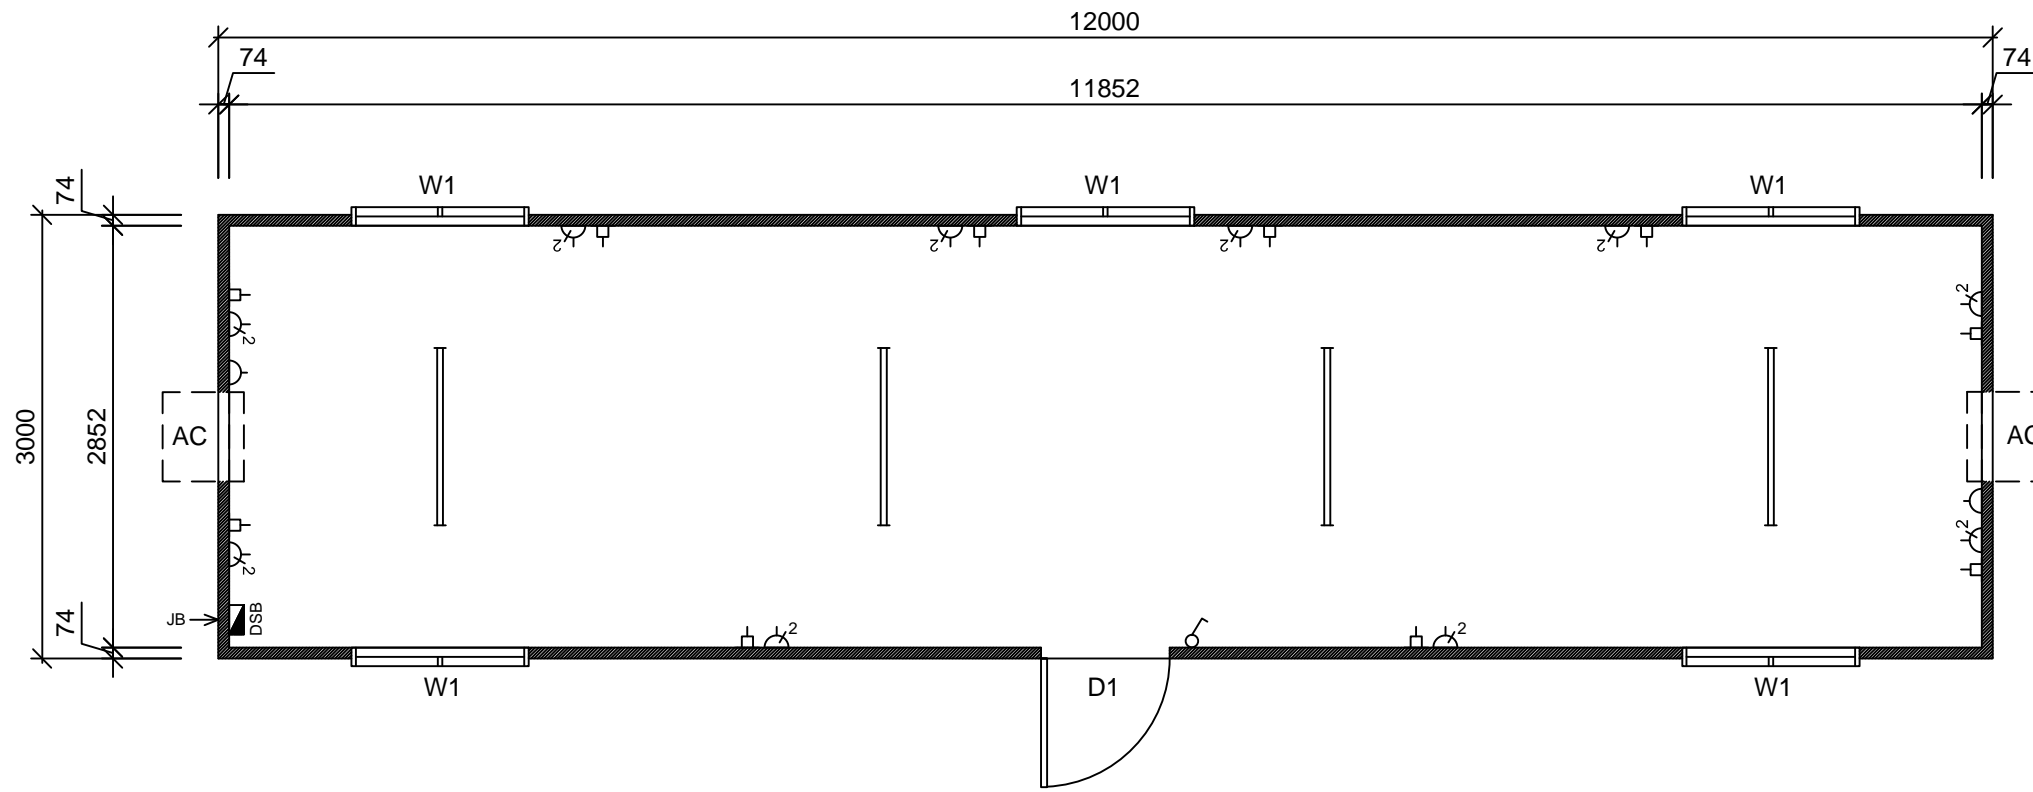

### 12.0x3.0m Office - Floor Plan

Scale 1:50

### Item List

Item	Qty	Description
D1	x(1)	2040x880mm External Metal Clad Door
W1	x(5)	900x1200mm Sliding Glass Window - Grey Glass
AC	x(2)	Frame & Cutout Only - For Wall Mounted Air Conditioner (Cutout Size - 610mm Wide x 390mm High)

### Notes

- Built to Multitrade Building Hire Specification
- 2400mm Internal Ceiling Height

### Electrical Legend

Icon	Qty	Description
	x(1)	Distribution Switchboard
	x(1)	Junction Box - Electrical Point Of Entry
	x(1)	Light Switch
	x(2)	10amp Single GPO
	x(10)	10amp Double GPO
	x(10)	Draw Wire With Blank Plate
	x(4)	36 Watt Double Fluorescent Light

### Colour Schedule

External		
Cladding	-	Surfmist
Roof	-	Zincalume
Flashings	-	Surfmist
Capping	-	Surfmist
Door	-	White
Windows	-	White
Internal		
Vinyl	-	Grey
Walls	-	Grey
Ceiling	-	White

#### CLIENT APPROVAL

Signature: \_\_\_\_\_ Date: \_\_\_\_\_

Rev.	Description	Date	By
A	Issued for Client Review	22/11/13	BL

THIS DRAWING AND DESIGN IS THE SOLE PROPERTY OF JABEGIL PTY LTD T/A MULTITRADE BUILDING HIRE A.B.N. 36 010 138 600 IT MAY NOT BE REPRODUCED, COPIED WHOLE OR IN PART WITHOUT WRITTEN AUTHORITY.

CLIENT	DATE	
	22/11/13	
TITLE	SCALE	
12.0x3.0m OFFICE	1:50	
DESIGN WIND LOAD	DRAWN	CHECKED
C2 - CYCLONIC	BL	
DRAWING NUMBER	REVISION	SHEET SIZE
MBH-12030-OFF-01	A	A3