


G » Á Ô Ò Þ V Ü Ò Á Ú Q V Ô Þ Á Ü U U Ø

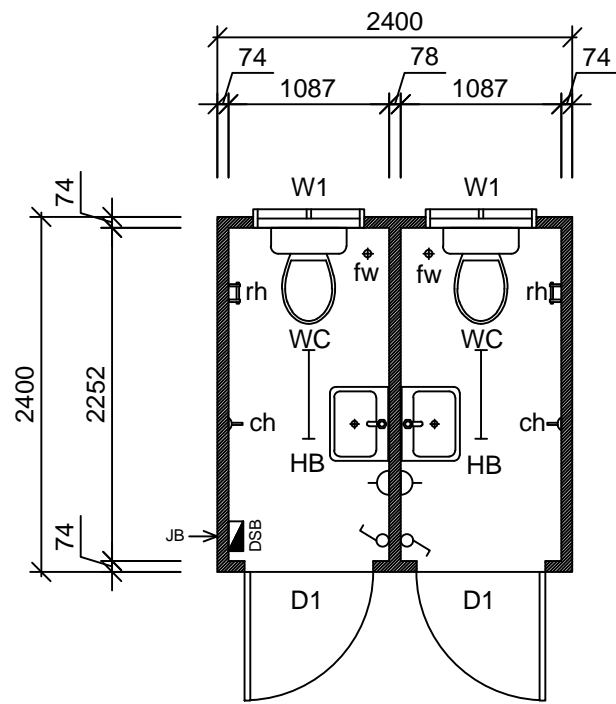

**2.4x2.4m Toilet Block - Floor Plan**

Scale 1:50

### Colour Schedule

<u>External</u>		
Cladding	-	Surfmist
Roof	-	Zincalume
Flashings	-	Surfmist
Capping	-	Surfmist
Door	-	White
Windows	-	White
<u>Internal</u>		
Vinyl (R10)	-	Grey
Walls	-	Grey
Ceiling	-	White

### Item List

Item	Qty	Description
D1	x(2)	2040x880mm External Metal Clad Door With Door Closer
W1	x(2)	300x750mm Sliding Obscure Glass Vented Window
WC	x(2)	Toilet Pan With Dual Flush Cistern
HB	x(2)	Stainless Steel Hand Basin - Cold Only, Mirror Over
rh	x(2)	Roll Holder
ch	x(2)	Coat Hook
fw	x(2)	Floor Waste

### Electrical Legend

Icon	Qty	Description
	x(1)	Distribution Switchboard
	x(1)	Junction Box - Electrical Point Of Entry
	x(2)	Light Switch
	x(2)	10amp Single GPO
	x(1)	18 Watt Single Fluorescent Light

### Notes

- Built to Multitrade Building Hire Specification
- 2400mm Internal Ceiling Height
- Coved R10 Slip Resistant Vinyl In Wet Areas

#### CLIENT APPROVAL

Signature: \_\_\_\_\_ Date: \_\_\_\_\_

Rev.	Description	Date	By
A	Issued for Client Review	22/11/13	BL

THIS DRAWING AND DESIGN IS THE SOLE PROPERTY OF JABEGIL PTY LTD T/A MULTITRADE BUILDING HIRE A.B.N. 36 010 138 600 IT MAY NOT BE REPRODUCED, COPIED WHOLE OR IN PART WITHOUT WRITTEN AUTHORITY.

CLIENT	DATE
	22/11/13
TITLE	SCALE
2.4x2.4m TOILET BLOCK	1:50
DESIGN WIND LOAD	DRAWN
C2 - CYCLONIC	BL
DRAWING NUMBER	REVISION
MBH-2424-TBL-01	A
	SHEET SIZE
	A3