


G» ÁÔËËVÛÒÁÚQVÔPÁÛUUØ

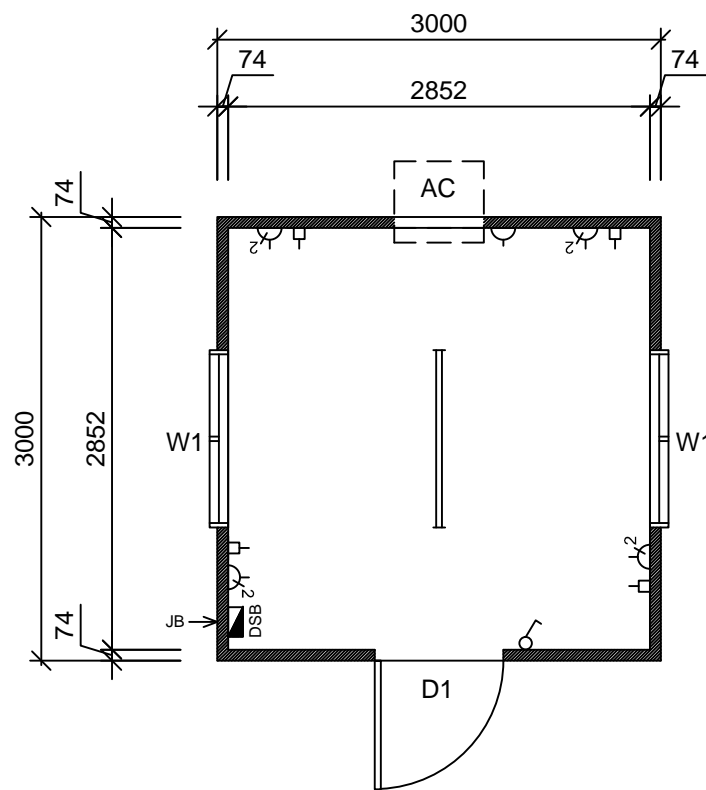

3.0x3.0m Office - Floor Plan

Scale 1:50

Colour Schedule

<u>External</u>		
Cladding	-	Surfmist
Roof	-	Zincalume
Flashings	-	Surfmist
Capping	-	Surfmist
Door	-	White
Window	-	White
<u>Internal</u>		
Vinyl	-	Grey
Walls	-	Grey
Ceiling	-	White

CLIENT APPROVAL			
Signature:		Date:	
Rev.	Description	Date	By
A	Issued for Client Review	22/11/13	BL
THIS DRAWING AND DESIGN IS THE SOLE PROPERTY OF JABEGIL PTY LTD T/A MULTITRADE BUILDING HIRE A.B.N. 36 010 138 600 IT MAY NOT BE REPRODUCED, COPIED WHOLE OR IN PART WITHOUT WRITTEN AUTHORITY.			
CLIENT		DATE	
		22/11/13	
TITLE		SCALE	
3.0x3.0m OFFICE		1:50	
DESIGN WIND LOAD	DRAWN	CHECKED	
C2 - CYCLONIC	BL		
DRAWING NUMBER	REVISION	SHEET SIZE	
MBH-3030-OFF-01	A	A3	

Item List

Item	Qty	Description
D1	x(1)	2040x880mm External Metal Clad Door
W1	x(1)	900x1200mm Sliding Glass Window - Grey Glass
AC	x(1)	Frame & Cutout Only - For Wall Mounted Air Conditioner (Cutout Size - 610mm Wide x 390mm High)

Notes

- Built to Multitrade Building Hire Specification
- 2400mm Internal Ceiling Height

Electrical Legend

Icon	Qty	Description
	x(1)	Distribution Switchboard
	x(1)	Junction Box - Electrical Point Of Entry
	x(1)	Light Switch
	x(1)	10amp Single GPO
	x(4)	10amp Double GPO
	x(4)	Draw Wire With Blank Plate
	x(1)	36 Watt Double Fluorescent Light