


Colour Schedule

External		
Cladding	-	Surfmist
Roof	-	Zincalume
Flashings	-	Surfmist
Capping	-	Surfmist
Door	-	White
Windows	-	White
Internal		
Vinyl (R10)	-	Grey
Walls	-	Grey
Ceiling	-	White
Cabinetry	-	White

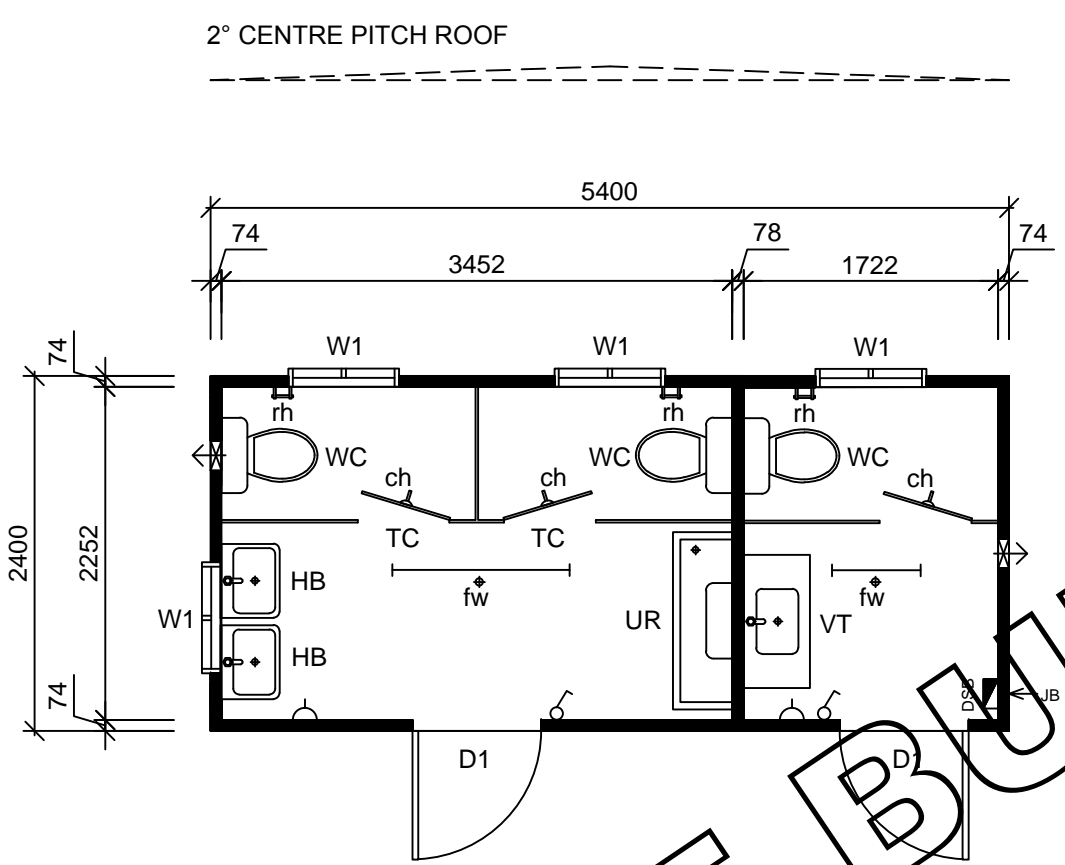

5.4x2.4m Toilet Block - Floor Plan

Scale 1:50

Item List

Item	Qty	Description
D1	x(2)	2040x850mm External Metal Clad Door With Door Closer
W1	x(4)	300x750mm Sliding Obscure Glass Vented Window
WC	x(3)	Toilet Pan With Dual Flush Cistern
TC	x(3)	Toilet Cubical With Door
UR	x(1)	1200mm Urinal With Cistern
HB	x(2)	Stainless Steel Hand Basin - Cold Only, Mirror Over
VT	x(1)	900mm Vanity Unit - Cold Only, Mirror Over
rh	x(3)	Roll Holder
ch	x(3)	Coal Hook
fw	x(2)	Floor Waste

Notes

- Built to Multitrade Building Hire Specification
- 2400mm Internal Ceiling Height
- Coved R10 Slip Resistant Vinyl In Wet Areas

Electrical Legend

Icon	Qty	Description
	x(1)	Distribution Switchboard
	x(1)	Junction Box - Electrical Point Of Entry
	x(2)	Light Switch
	x(2)	10amp Single GPO
	x(1)	18 Watt Single Fluorescent Light
	x(1)	36 Watt Single Fluorescent Light
	x(2)	Wall Mounted Exhaust Fan

CLIENT APPROVAL			
Signature:		Date:	

Rev.	Description	Date	By
A	Issued for Client Review	22/11/13	BL



THIS DRAWING AND DESIGN IS THE SOLE PROPERTY OF JABEGIL PTY LTD T/A MULTITRADE BUILDING HIRE A.B.N. 36 010 138 600 IT MAY NOT BE REPRODUCED, COPIED WHOLE OR IN PART WITHOUT WRITTEN AUTHORITY.

CLIENT	DATE
	22/11/13
TITLE	SCALE
5.4x2.4m TOILET BLOCK	1:50
DESIGN WIND LOAD	DRAWN
C2 - CYCLONIC	BL
DRAWING NUMBER	REVISION
MBH-5424-TBL-01	A
	CHECKED
	SHEET SIZE
	A3